


THE MINISTRY OF  
PUBLIC WORKS

P.O. Box HM525, Hamilton, HMGX, Bermuda  
Phone: (441)295-5151

DEPARTMENT OF WORKS  
AND ENGINEERING  
Fax: (441)292-4219

*Water and Wastewater Section*

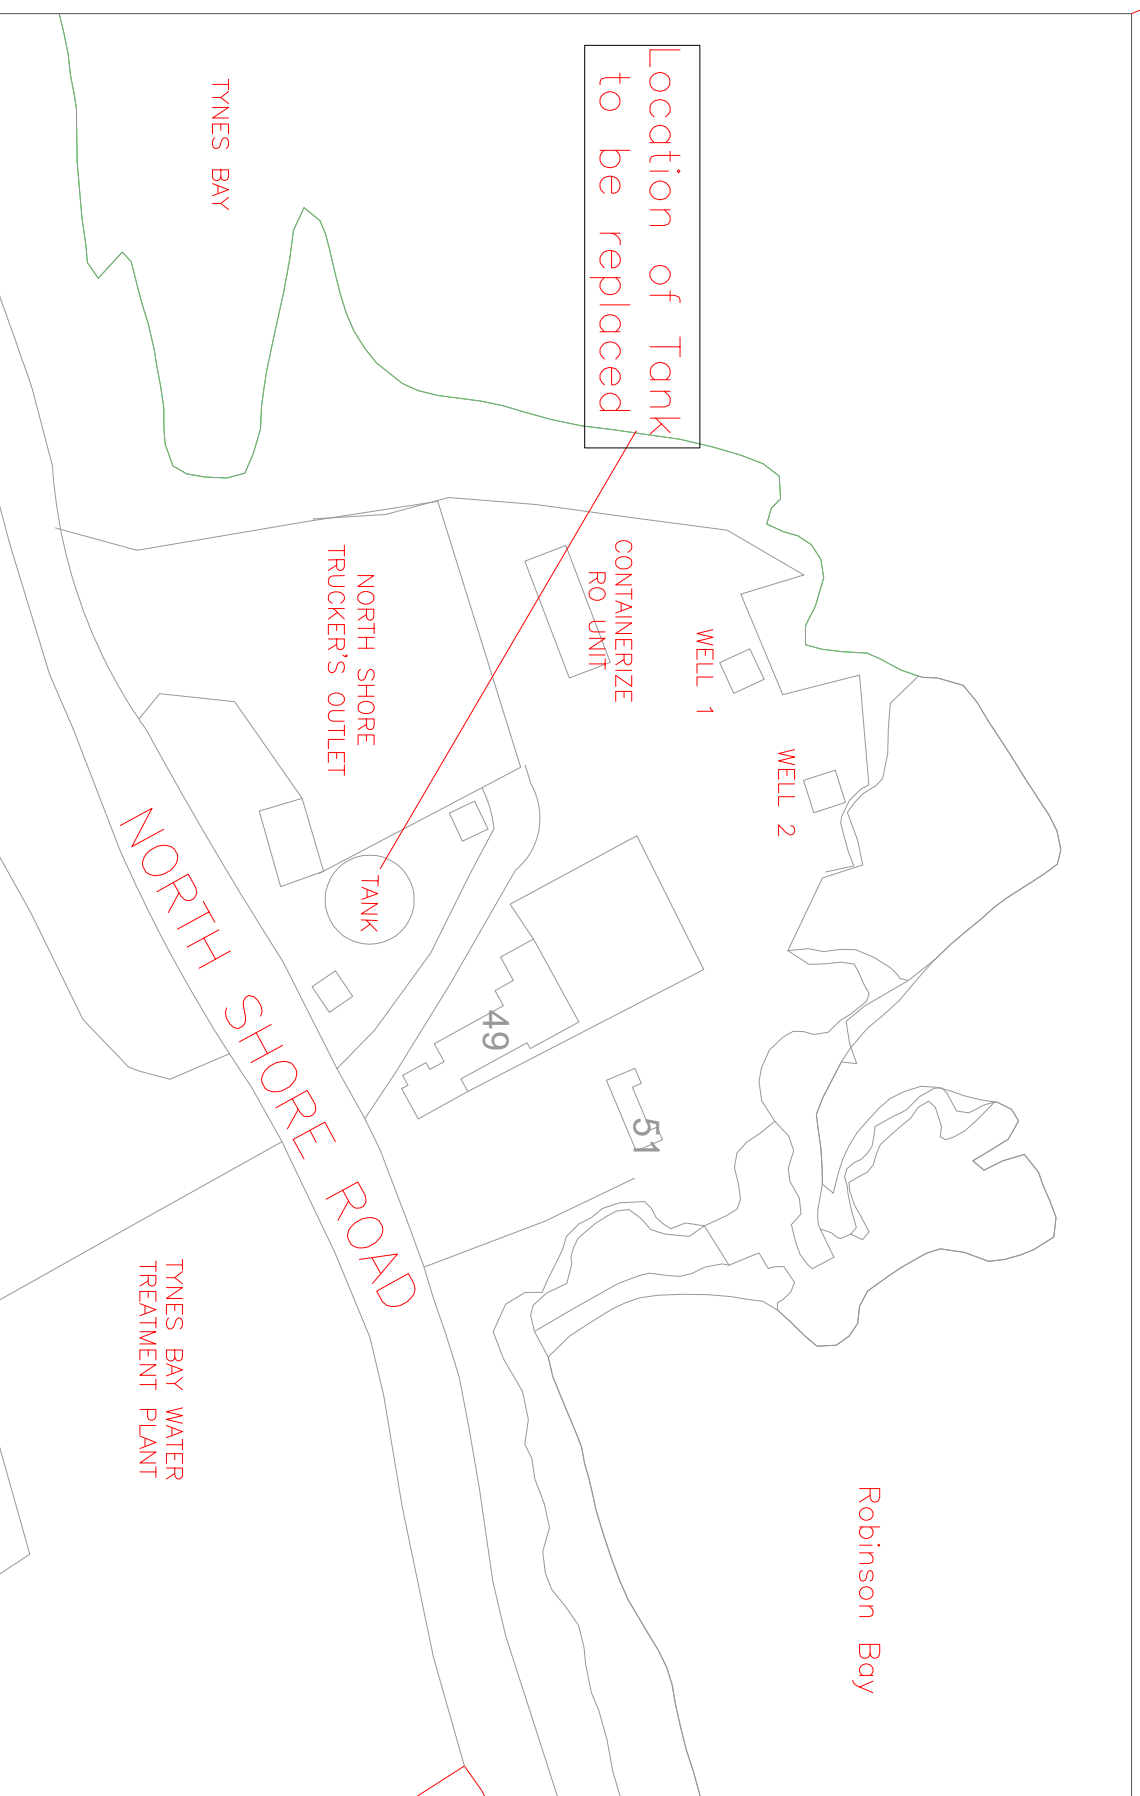

SITE PLAN

ISSUED FOR: Request for Proposal

AMENDMENTS:	NO	REVISION	BY	APPL	DATE

SCALE: NTS

SURVEY  
PREPARED BY: DATE:

DESIGN  
PREPARED BY: DATE:

CHECKED BY: DATE:

DRAWING  
PREPARED BY: DATE: 30/10/16

CHECKED BY: DATE: 30/10/16

APPROVED BY: DATE: 30/10/16

PROJECT NUMBER: -

PROJECT NAME:  
North Shore  
Water Truckers Outlet  
Water Storage Tank

North Shore Road  
Devonshire DV05

SHEET TITLE:  
SITE PLAN

SHEET NUMBER: C01

REVISION

ACAD 2002