

ISSUED FOR: AS BUILT 25/05/01

AMENDMENTS:

NO:	REVISION	APP	DATE:
A	BELCO ROOM	KC	29/SEP/99

SCALE: AS SHOWN

SURVEY

PREPARED BY: OS DATE: 12/1/2015

DESIGN

PREPARED BY: KC DATE: 12/1/2015

CHECKED BY: KC DATE: 12/1/2015

DRAWING

PREPARED BY: KC DATE: 12/1/2015

CHECKED BY: KC DATE: 12/1/2015

APPROVED BY: KC

PROJECT NUMBER: 50816


PROJECT NAME:
PROSPECT WATER DEPOT REMOTE MONITORING
FORT PROSPECT
14 HEADQUARTERS HILL
DEVONSHIRE

DRAWING FILE NO:
K:WATER SECTION\PROSPECT\DATA MONITORING

SHEET TITLE:
SITE AND LOCATION PLAN

SHEET NUMBER:
01

REVISION
A

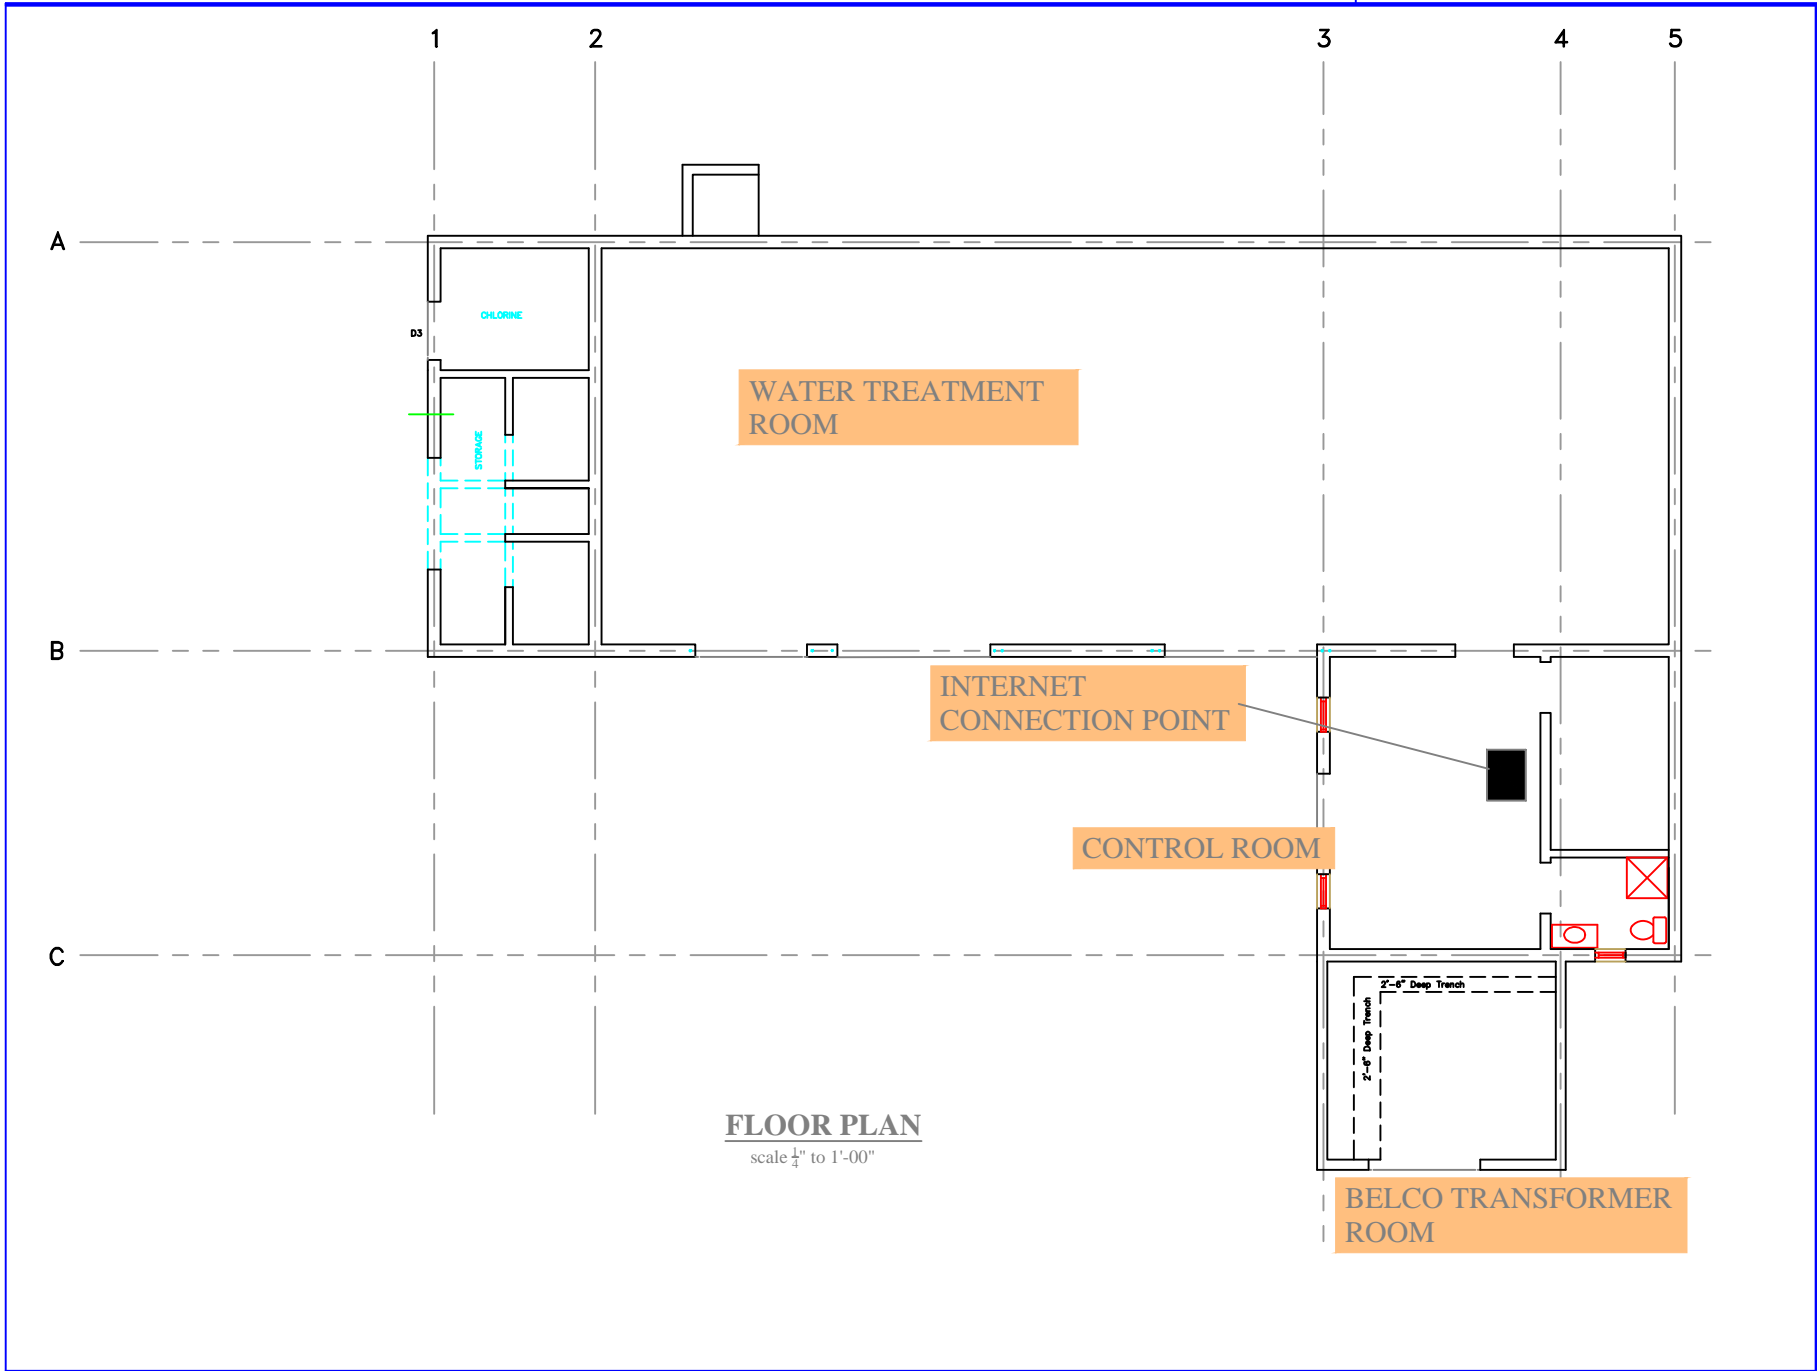

FLOOR PLAN
scale $\frac{1}{4}$ " to 1'-00"

**THE MINISTRY OF
PUBLIC WORKS**

P.O. Box 85828 Hamilton HM8X Bermuda
Phone: (441)296-5151

DEPARTMENT OF
WORKS & ENGINEERING

Water Section

ISSUED FOR: PLANNING 29/SEP/99

AMENDMENTS:

NO.	REVISION	APP.	DATE

SCALE: 1/4"=1'-0"

SURVEY

PREPARED BY: NA DATE: NA

DESIGN

PREPARED BY: KC DATE: 1/12/2015

CHECKED BY: KC DATE: 1/12/2015

DRAWING

PREPARED BY: KC DATE: 1/12/2015

CHECKED BY: KC DATE: 1/12/2015

APPROVED BY: KC

PROJECT NUMBER:

PROJECT NAME:

**PROSPECT
WATER DEPOT
REMOTE MONITORING**
FORT PROSPECT
14 HEADQUARTERS HILL
DEVONSHIRE

DRAWING FILE NO: ACAD R-12

SHEET TITLE:

**TREATMENT BUILDING
LAYOUT PLAN**

SHEET NUMBER:

02

REVISION

